



REVISIONS		
No.	DATE	ITEM
1	5-9-47	QUANTITY HAVE BEEN CIRCLED
2	5-24-47	REVISIONS, ADDITIONS OR DELETIONS ARE SHOWN CIRCLED

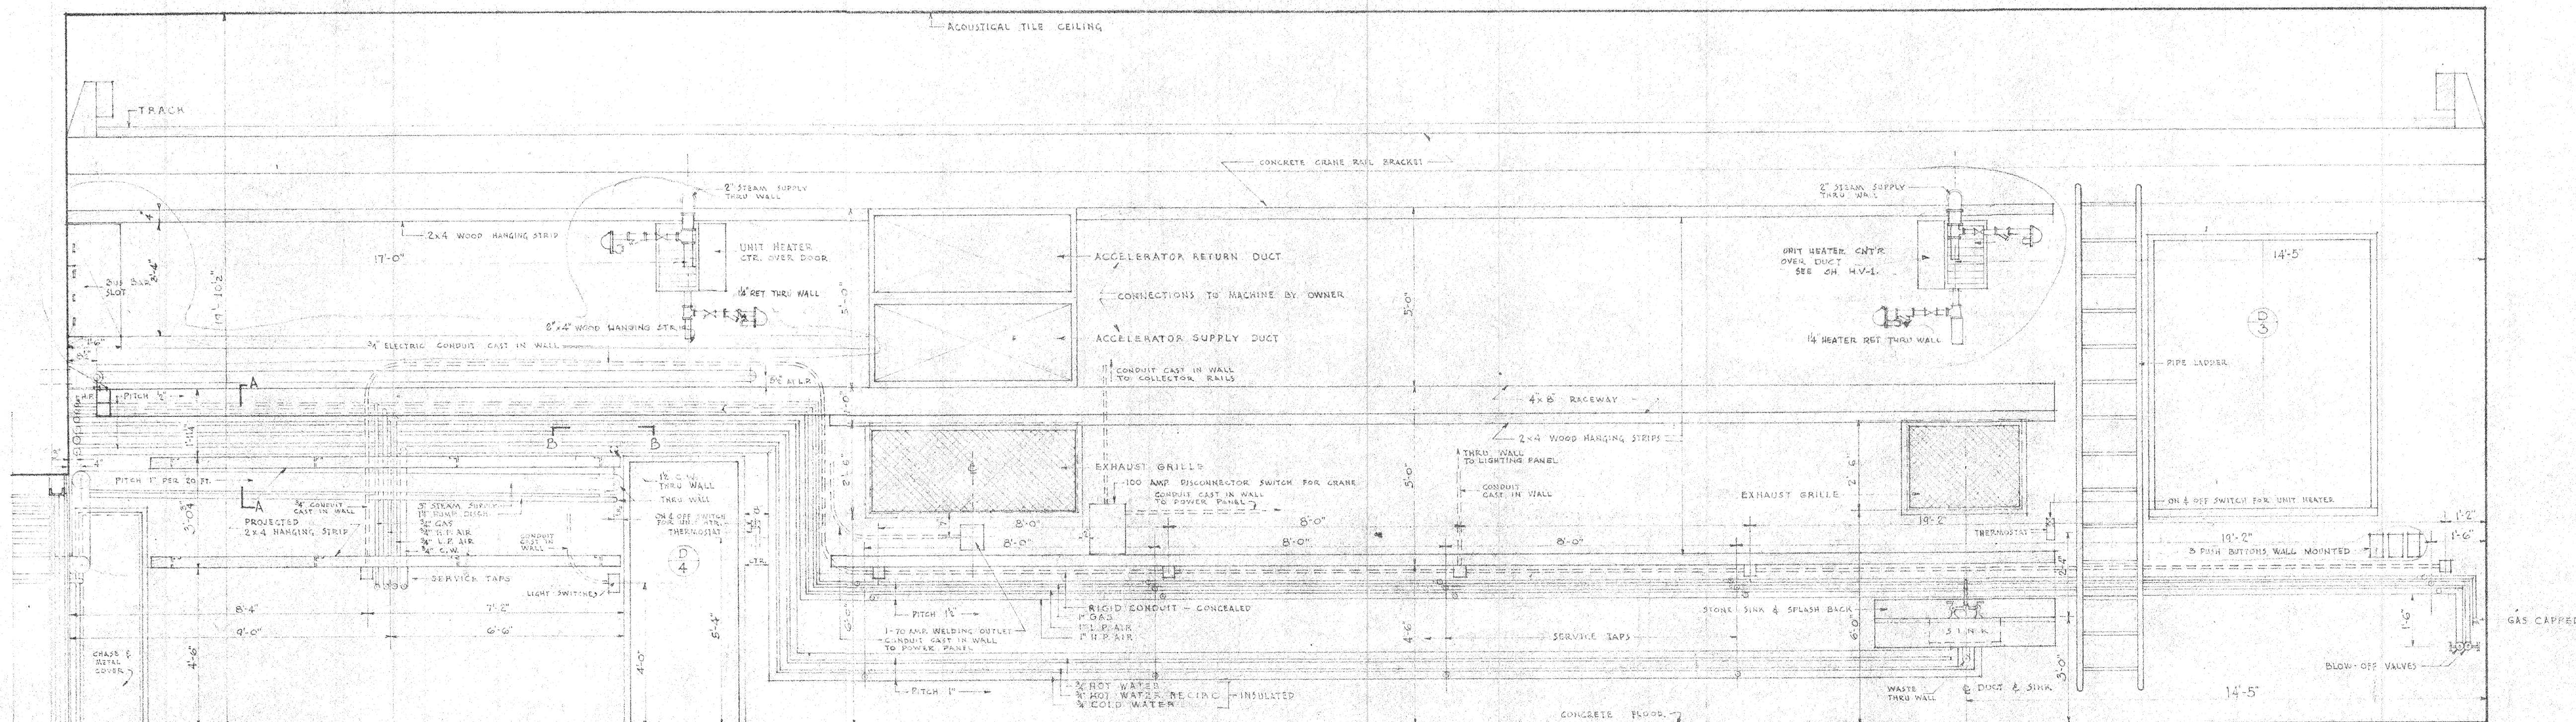

NORTHWEST ELEVATION


SCALE: 3/8" = 1'-0"

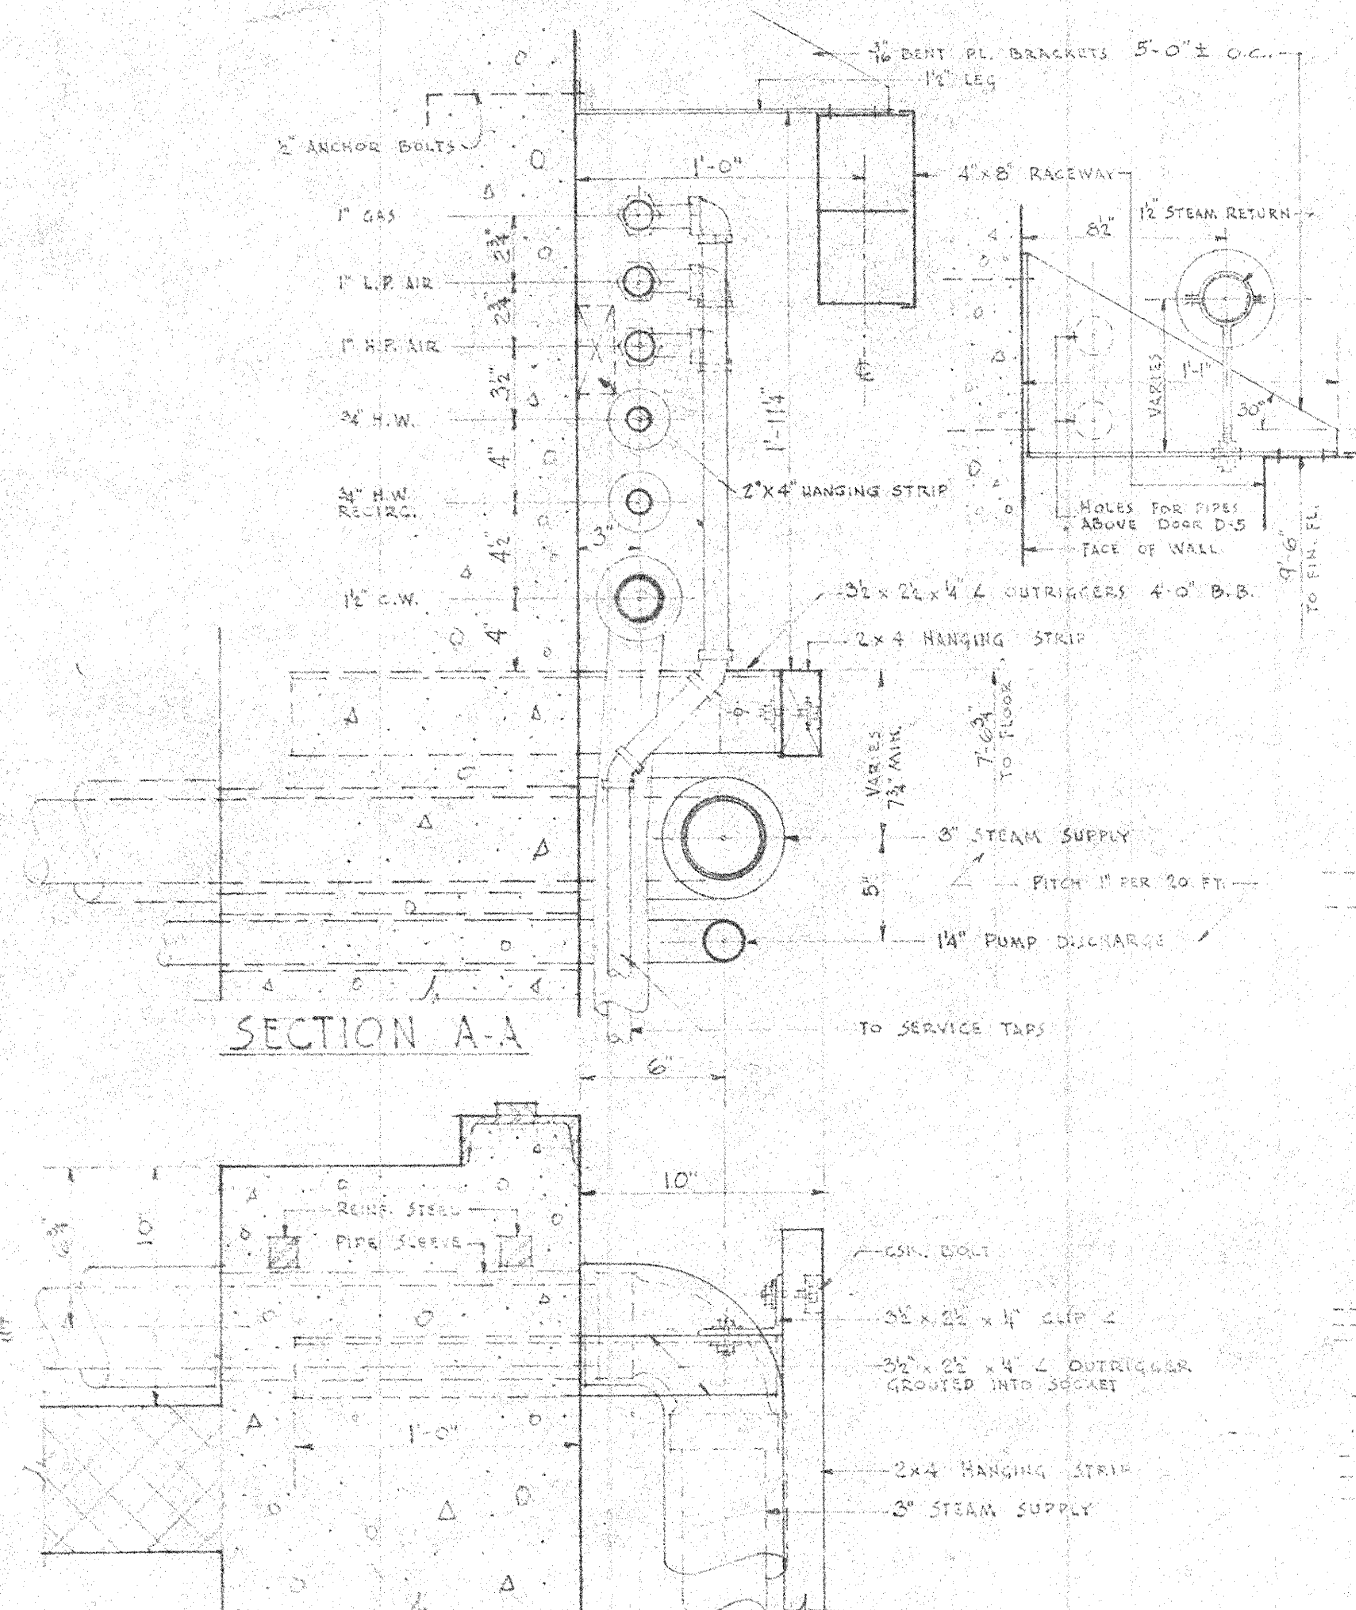

SECTION A-A


PLAN AT B-B

SCALE: 1/2" = 1'-0"

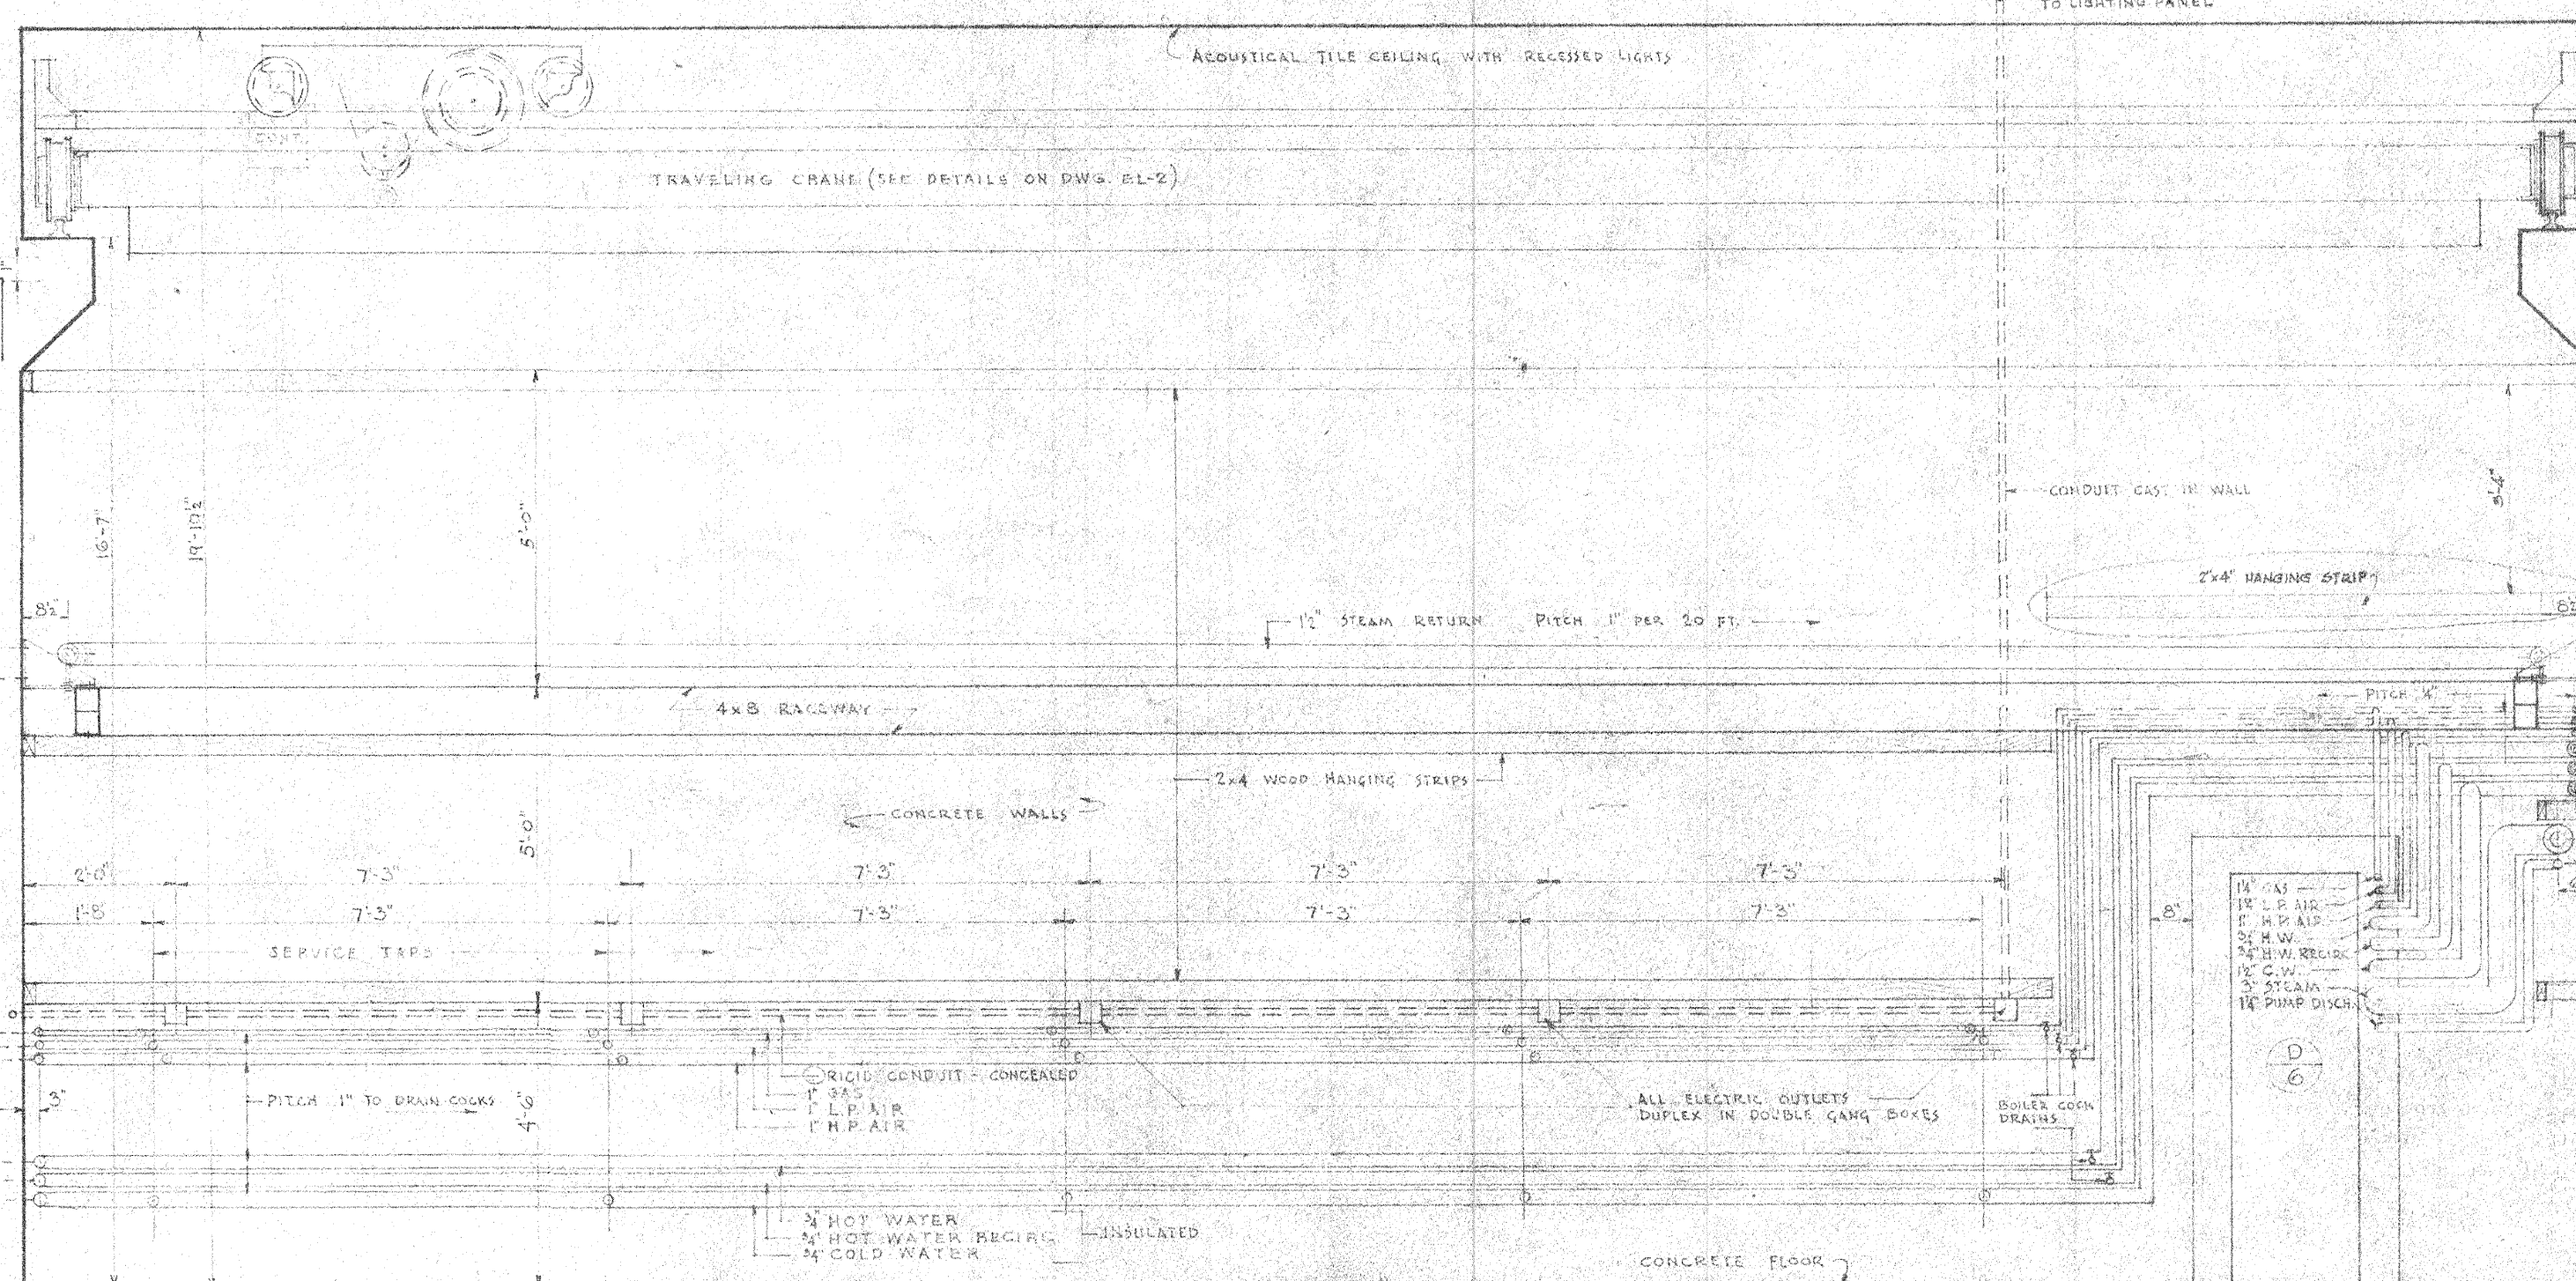

SOUTHWEST ELEVATION

SCALE: 3/8" = 1'-0"

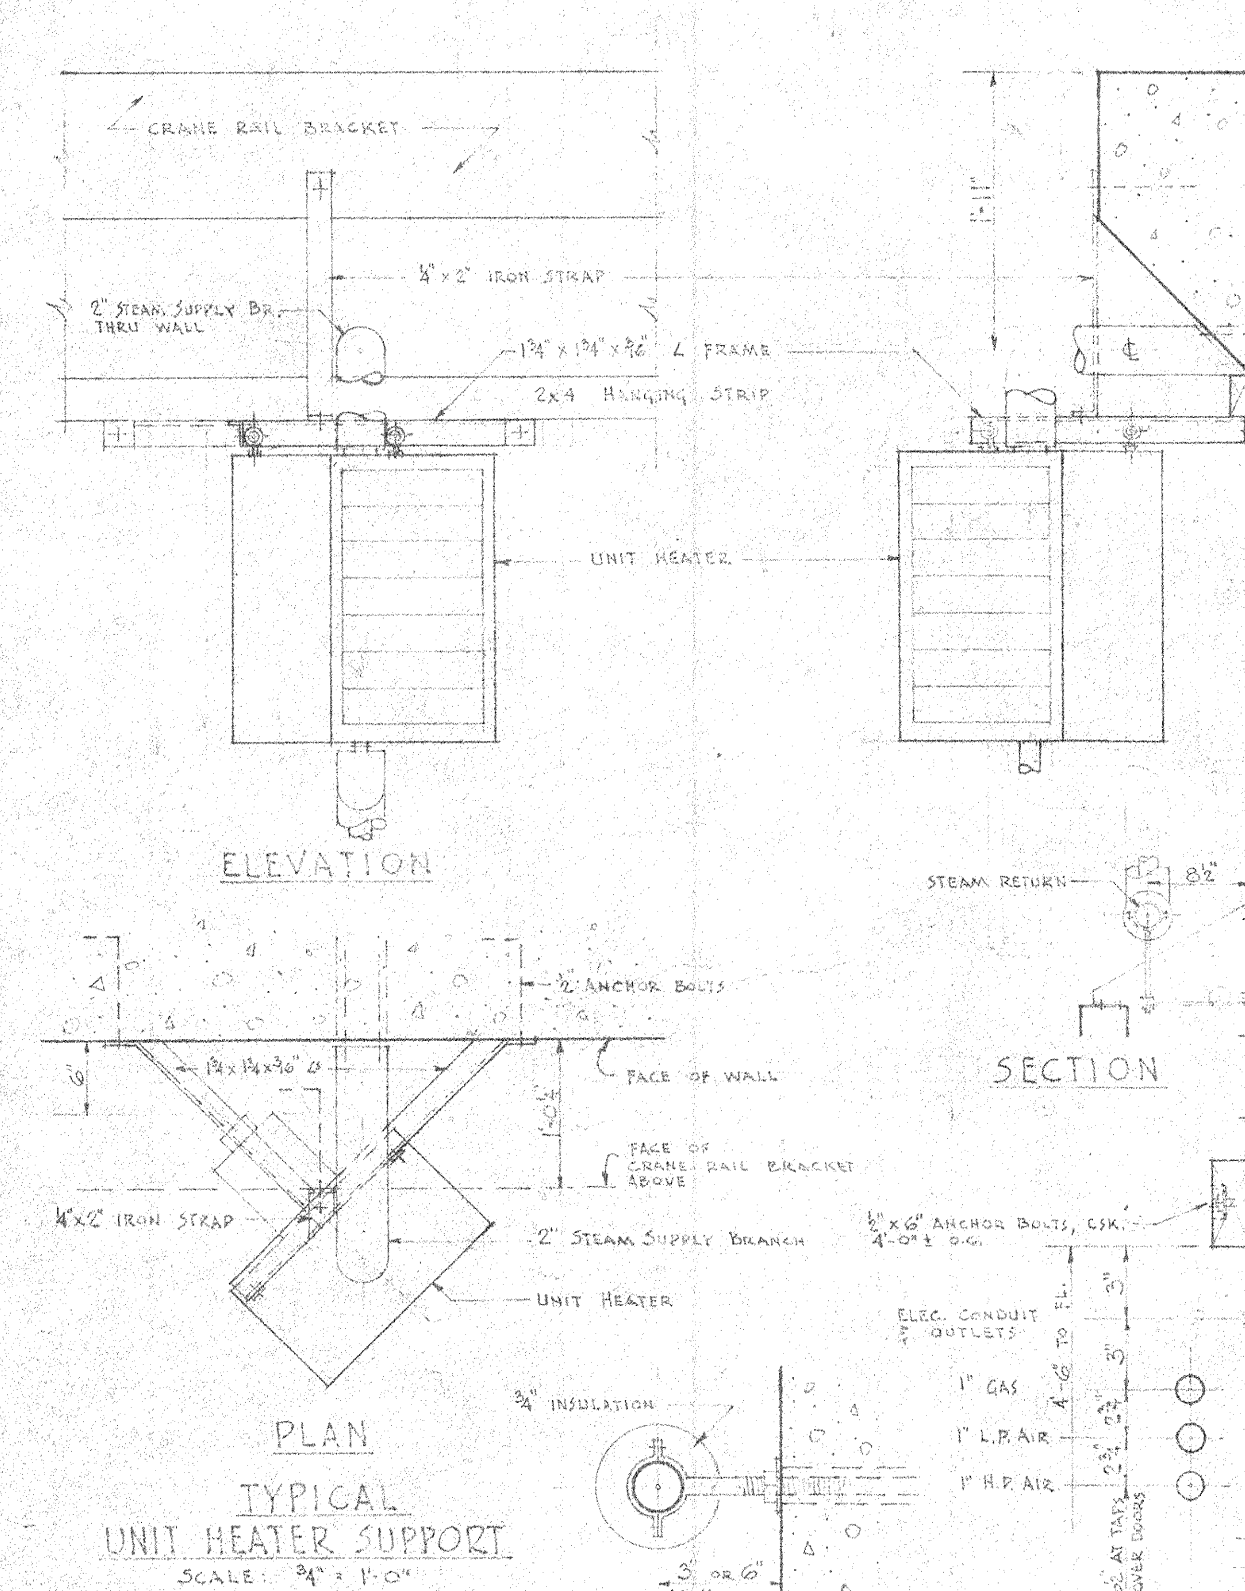

ELEVATION

SECTION

TYPICAL UNIT HEATER SUPPORT

SCALE: 3/8" = 1'-0"


TYPICAL PIPE SUPPORT

SCALE: 3/8" = 1'-0"

TYPICAL PIPE SPACING

SCALE: 1/2" = 1'-0"

(DIMENSIONS ARE AT W.B. OF RINGS)

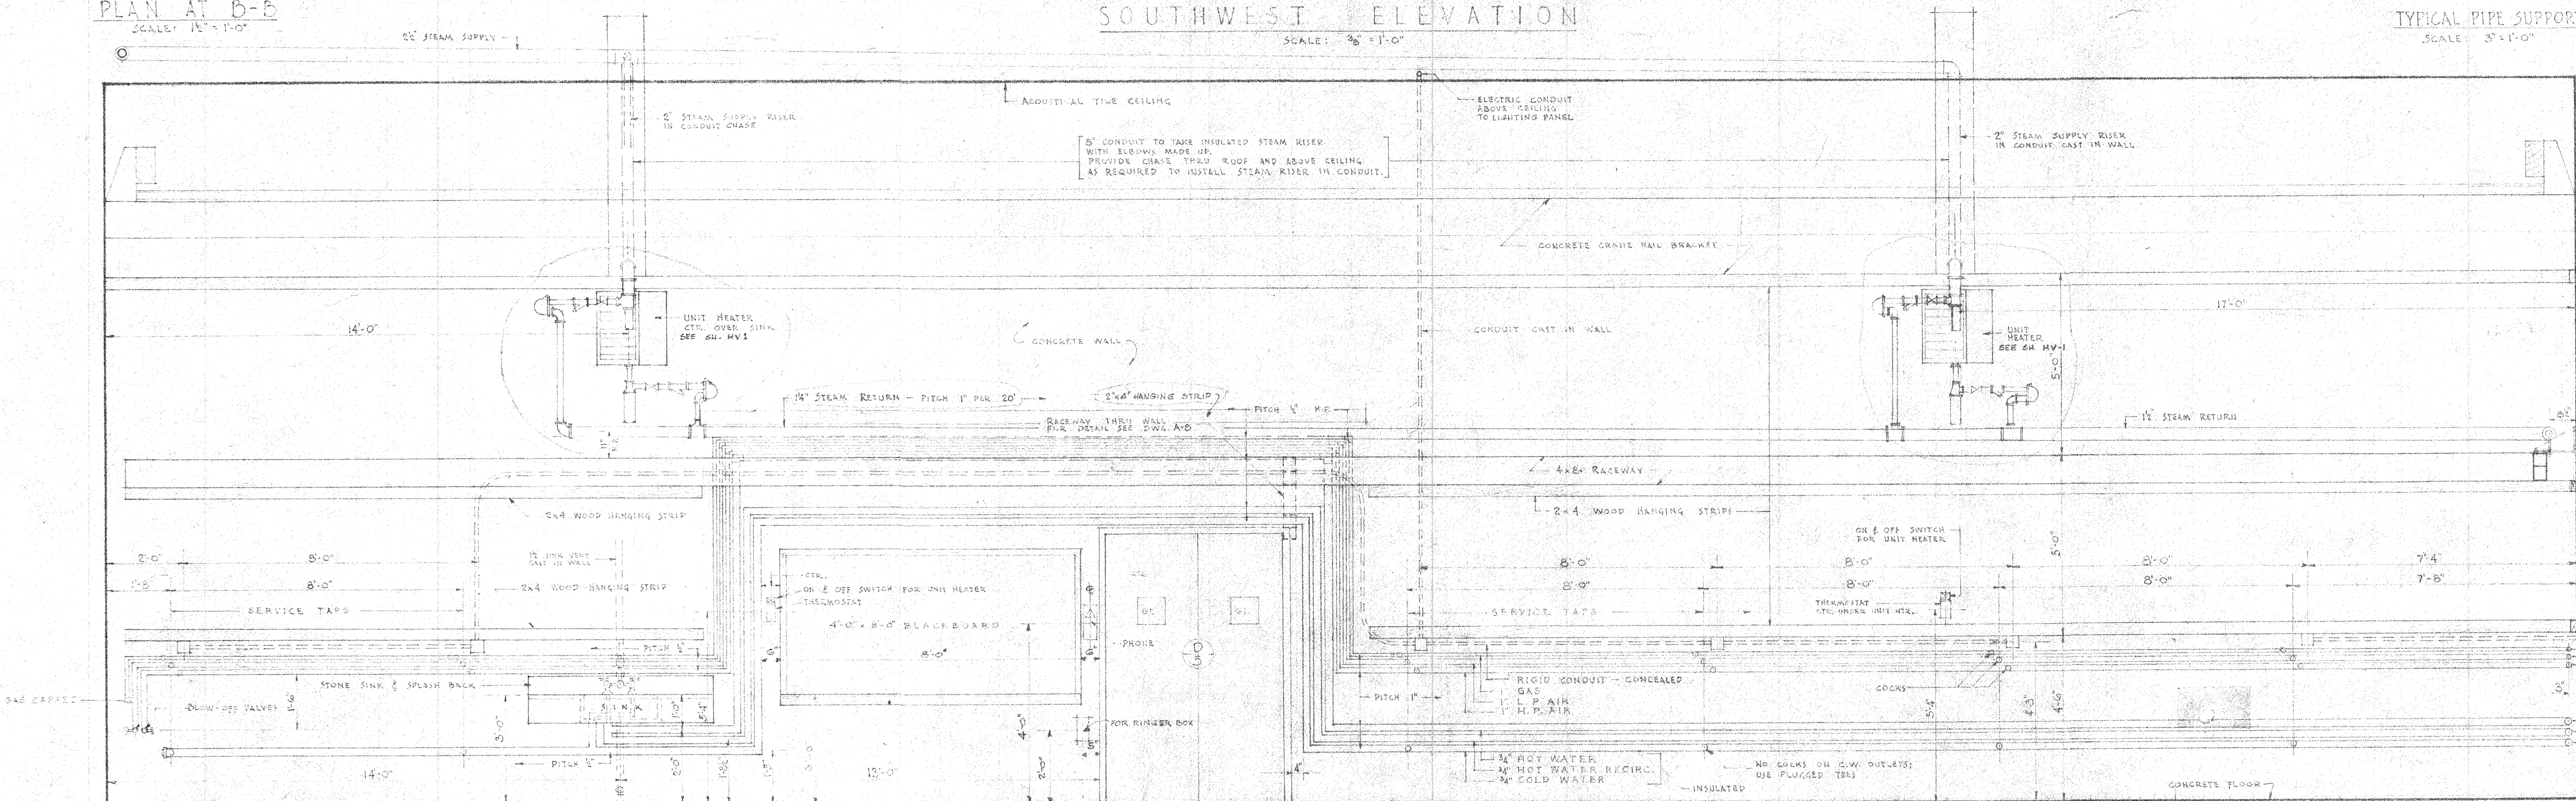


SOUTHEAST ELEVATION

SCALE: 3/8" = 1'-0"

GENERAL NOTES

1. ALL HORIZONTAL PIPING 1/2" AND OVER SHALL HAVE HANGERS AND SUPPORTS AT LEAST EVERY 10 FEET. 5/8" PIPE 1" AND LESS SHALL BE SUPPORTED BY HANGERS NOT MORE THAN 8'-0" O.C. ALL EXPOSED PIPING TO BE EVENLY SPACED FOR UNIFORM APPEARANCE.
2. ALL ELECTRIC CONDUITS RUN CONCEALED, CASE IN WALLS.
3. LOCATIONS OF ALL SERVICE OUTLETS AND EQUIPMENT SHOWN IN THIS DRAWING SHALL TAKE PRECEDENCE OVER ANY OTHER DRAWING.
4. SECURE 2x4 WOOD HANGING STRIPS TO WALLS WITH 2x4 ANCHOR BOLTS 4'-0" O.C. NOT TO BE 6x6 BLUM WITH FACE OF STRIP.
5. MOUNT THERMOSTATS & OTHER UNIT HEATER CONTROLS 7' OUT FROM WALLS. SEE N.E. OF SECT. 17 OF SPEC.

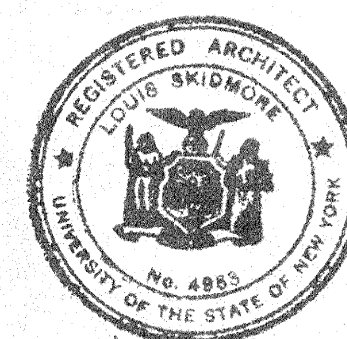

LABORATORY OF NUCLEAR STUDIES
CORNELL UNIVERSITY - ITHACA, N. Y.
SKIDMORE OWINGS & MERRILL
ARCHITECTS
5 EAST 57 STREET - NEW YORK, N. Y.

ACCELERATOR BUILDING
ACCELERATOR RIA ELEVATIONS

DRAWN J.C.	DATE 5-9-47	DRAWING NUMBER A7a
CHECKED J.C.	SCALE AS NOTED	