




REVISIONS		
NO.	DATE	ITEM
1	5-10-47	CHANGED MADE HAVE BEEN CIRCLED
2	5-14-47	REMOVED ADDITIONS OR DELETIONS ARE SHOWN CIRCLED

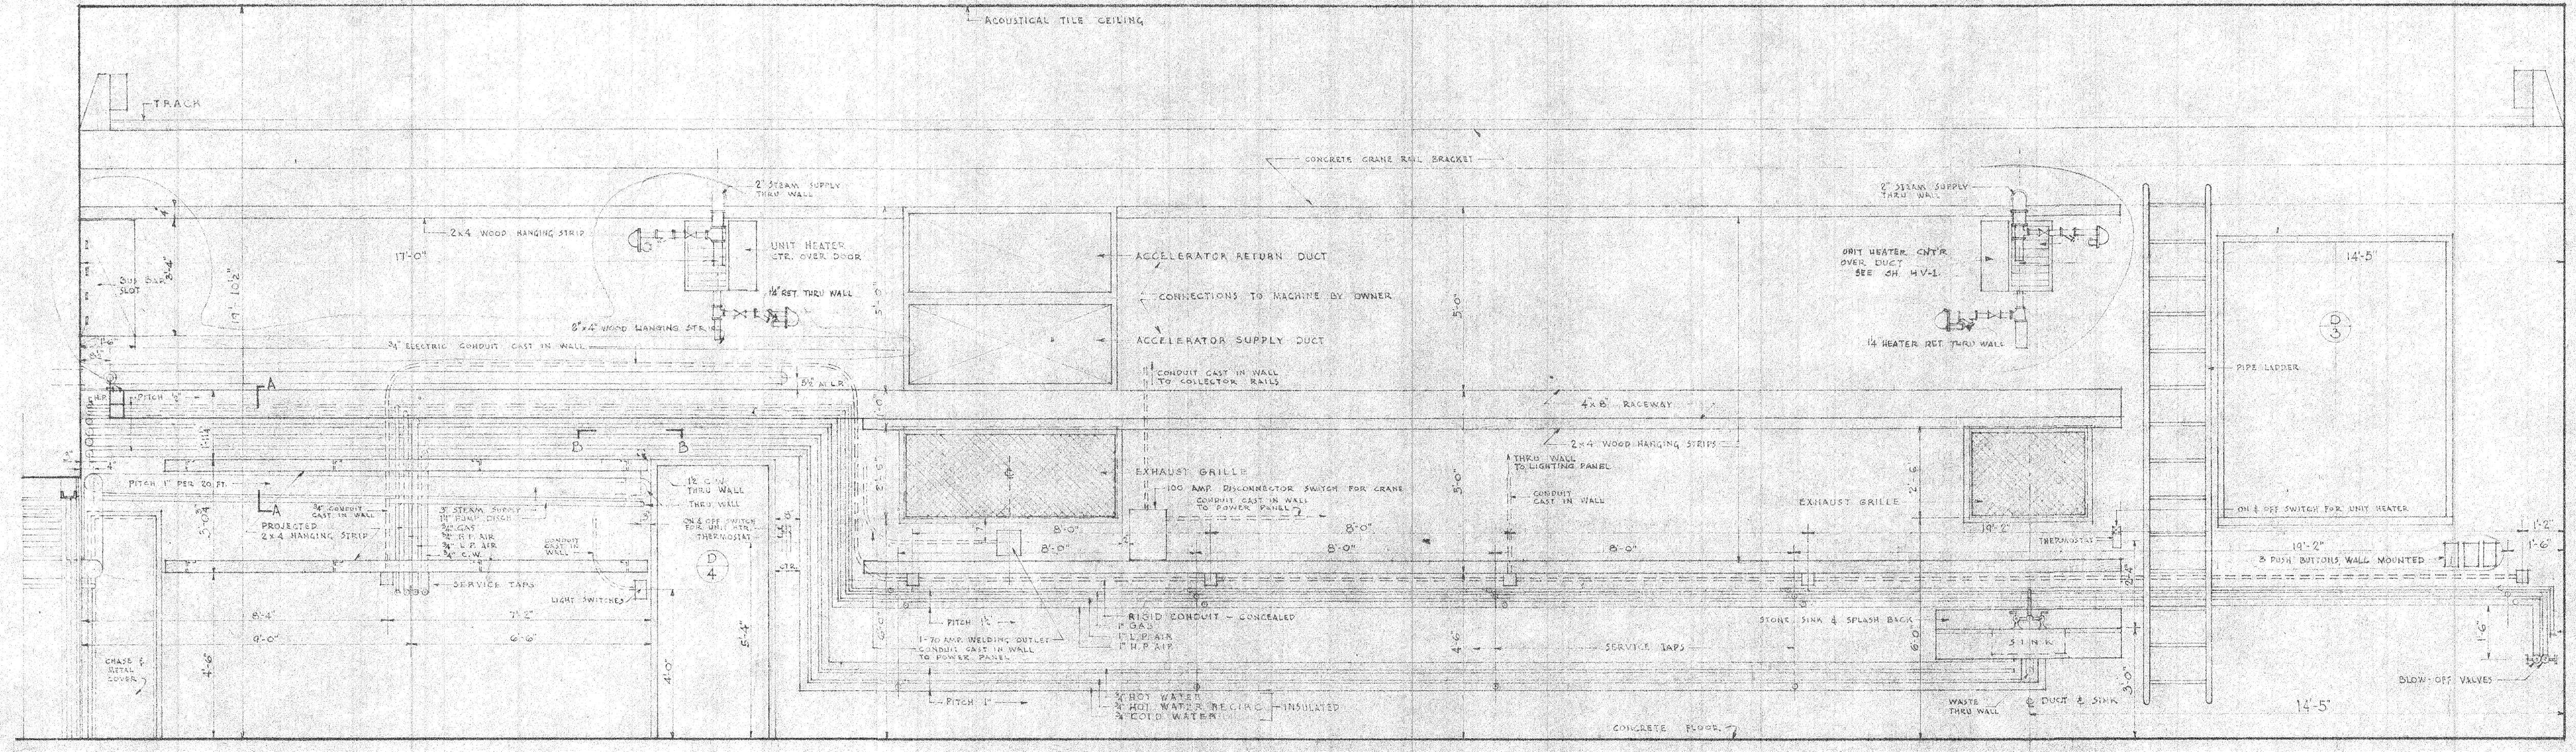


NORTHWEST ELEVATION
SCALE: 3/8\"/>

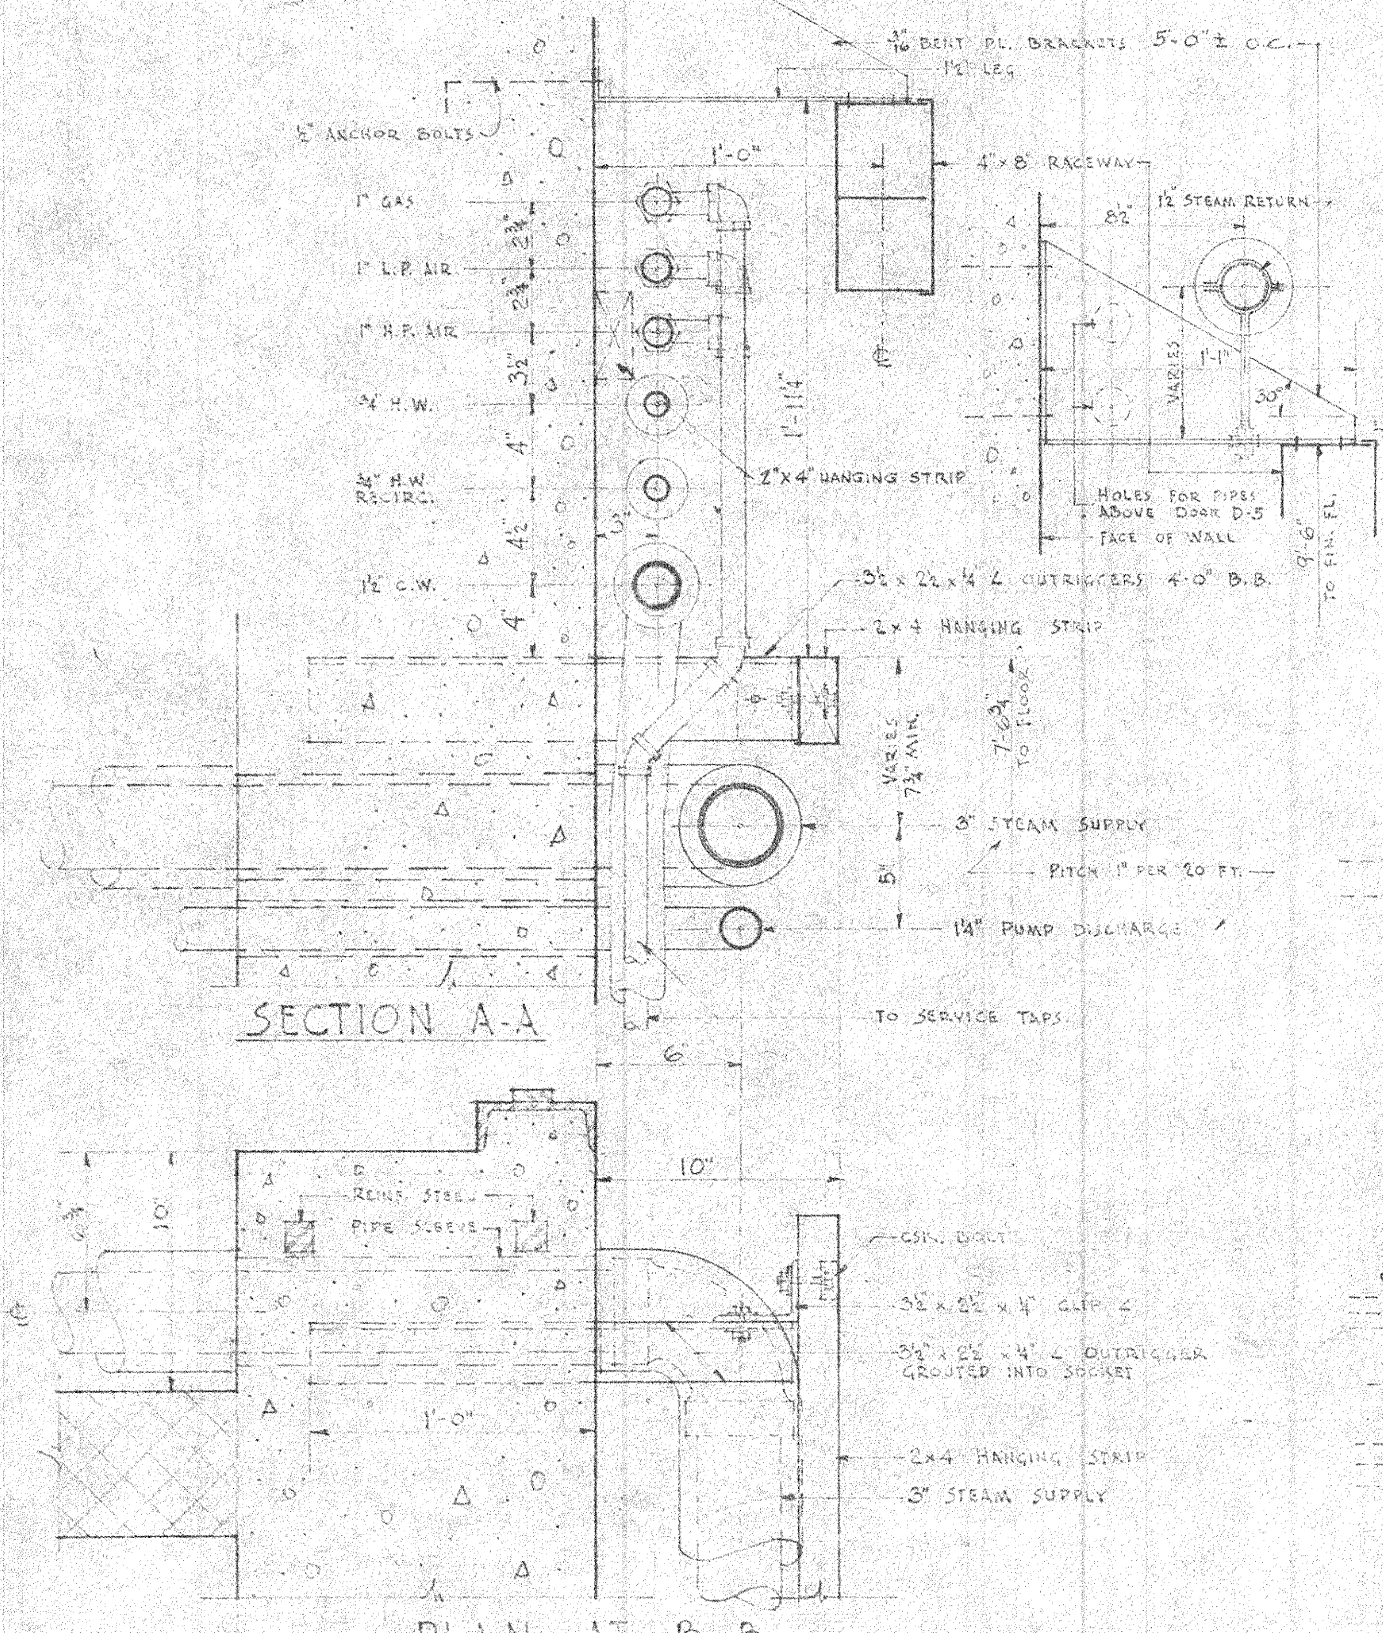

SECTION A-A
SCALE: 1/2\"/>

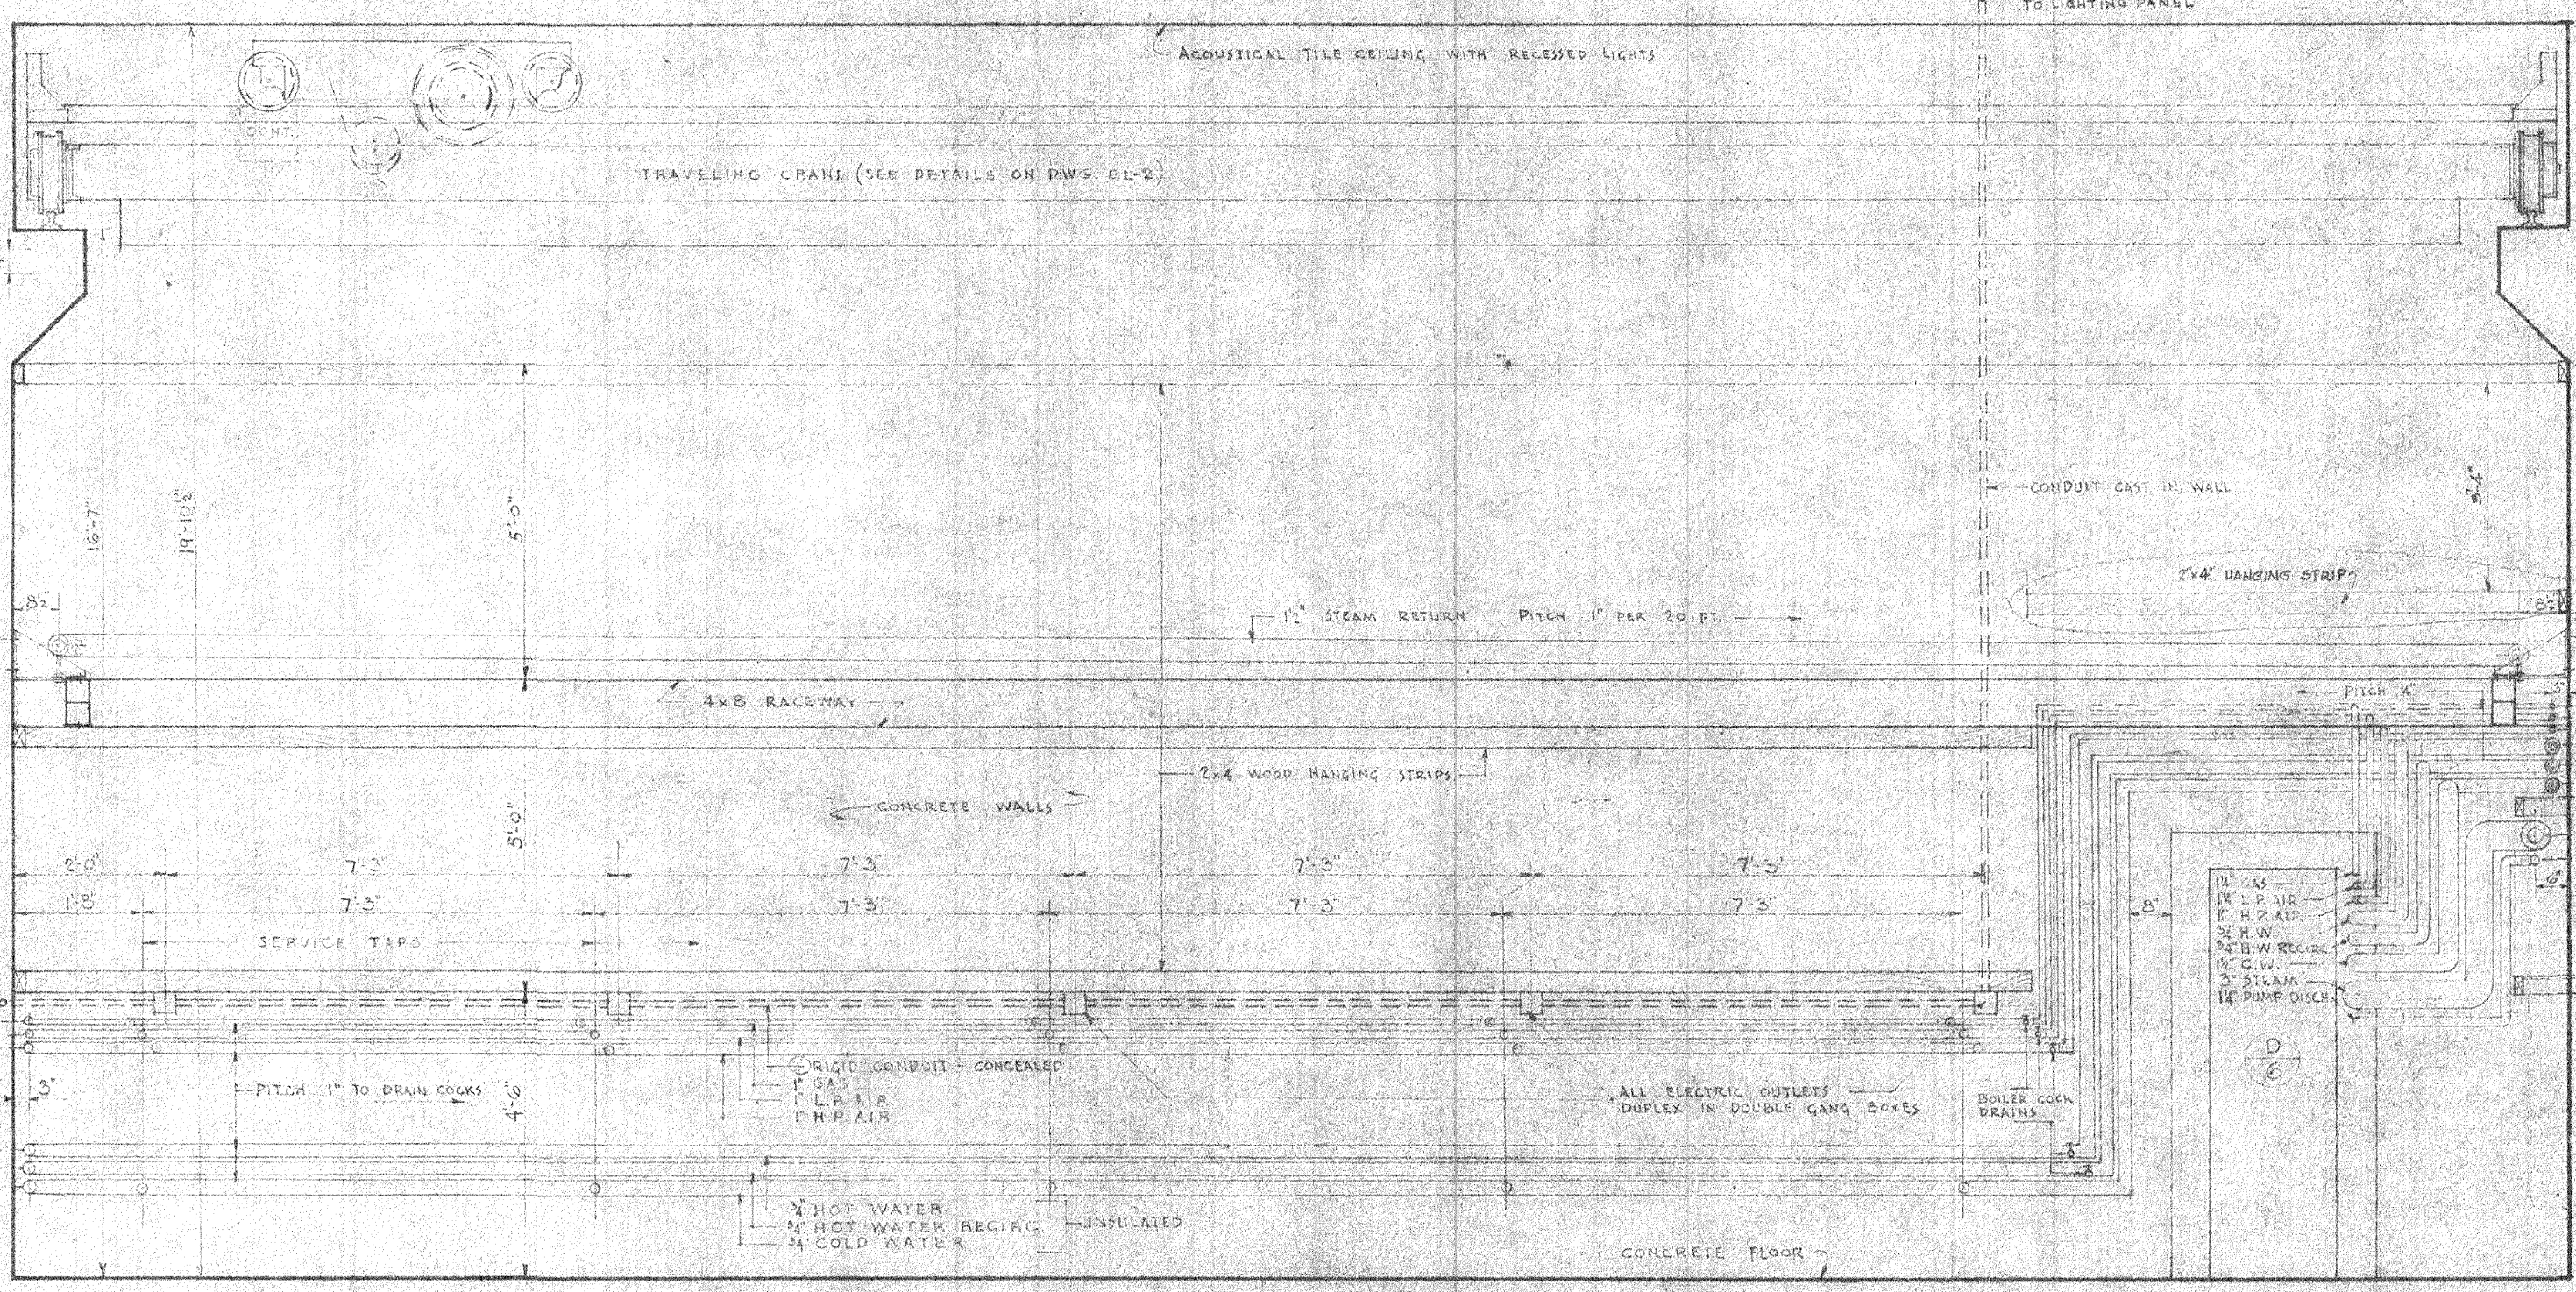

SOUTHWEST ELEVATION
SCALE: 3/8\"/>

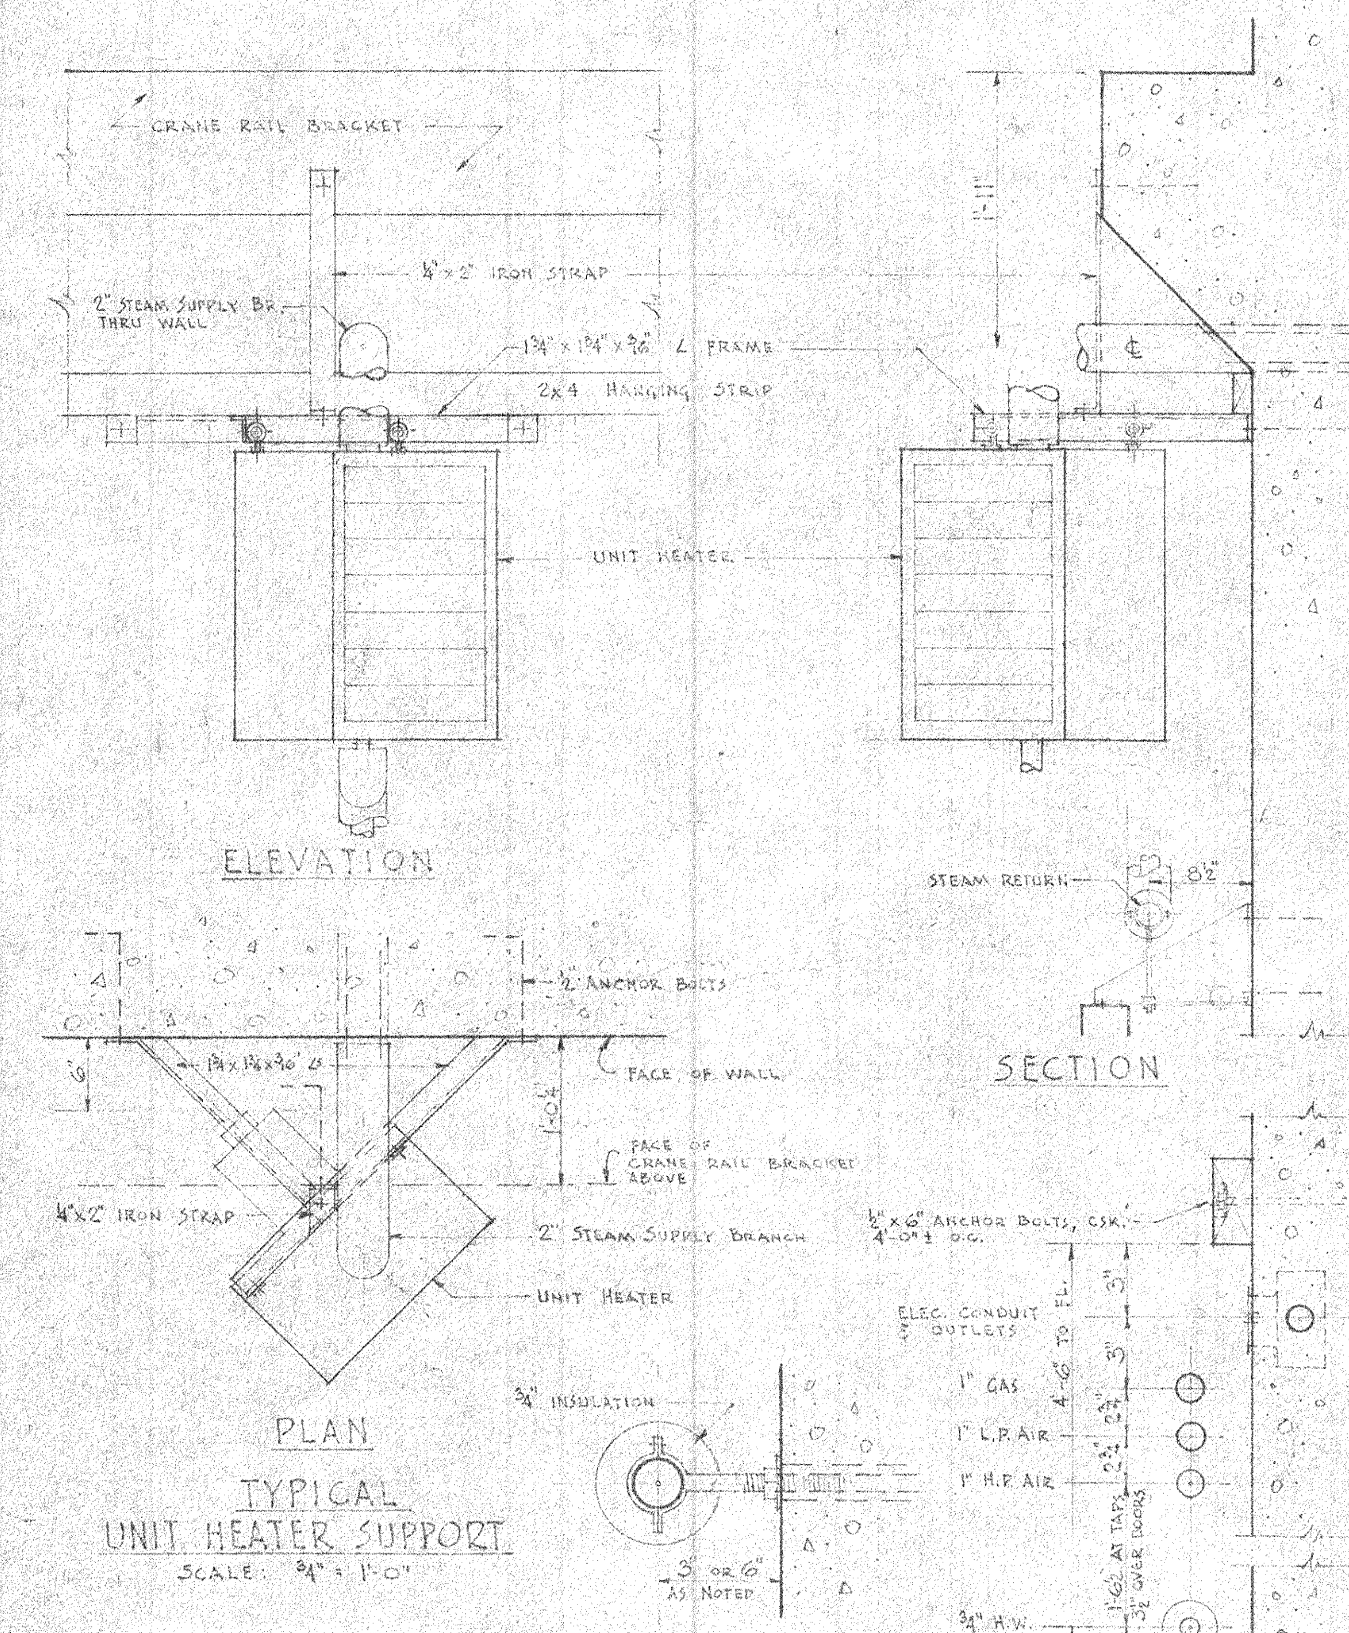

ELEVATION


SECTION

PLAN

TYPICAL UNIT HEATER SUPPORT
SCALE: 3/8\"/>

TYPICAL PIPE SUPPORT
SCALE: 3/8\"/>

TYPICAL PIPE SPACING
SCALE: 1/2\"/>

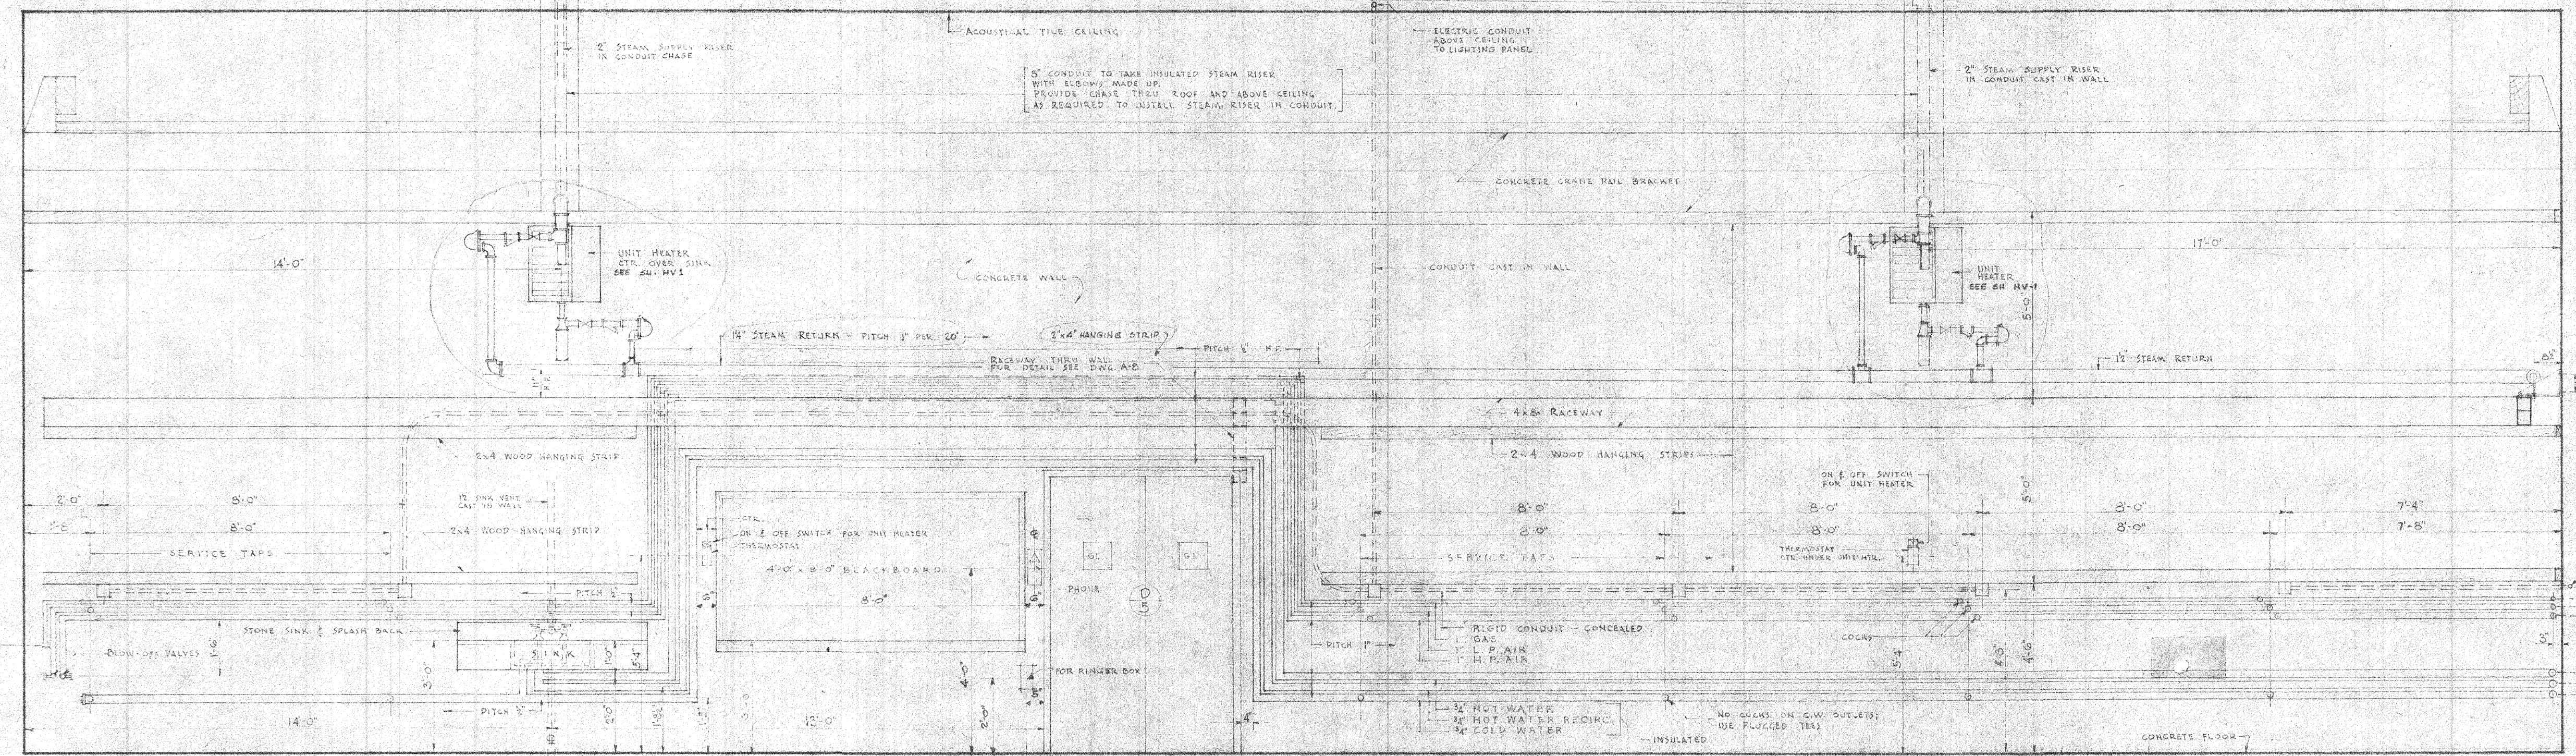

SOUTHEAST ELEVATION
SCALE: 3/8\"/>

GENERAL NOTES

2. ALL HORIZONTAL PIPING IN AND OVER SHALL HAVE HANGERS AND SUPPORTS AT LEAST EVERY 10 FEET. PIPING 1\"/>



LABORATORY OF NUCLEAR STUDIES
CORNELL UNIVERSITY - ITHACA, N. Y.
SKIDMORE OWINGS & MERRILL
ARCHITECTS
5 EAST 57 STREET - NEW YORK, N. Y.

ACCELERATOR BUILDING
ACCELERATOR R.M. ELEVATIONS

DRAWN J.C.	DATE 5-9-47	DRAWING NUMBER A7a
CHECKED J.S.	SCALE AS NOTED	