




REVISIONS		
NO.	DATE	DESCRIPTION
1	5-10-47	CHANGED MADE HAVE BEEN CIRCLED
2	5-10-47	REMOVED ADDITIONS FOR CLARITY AND
3	5-10-47	DOWN CIRCLED

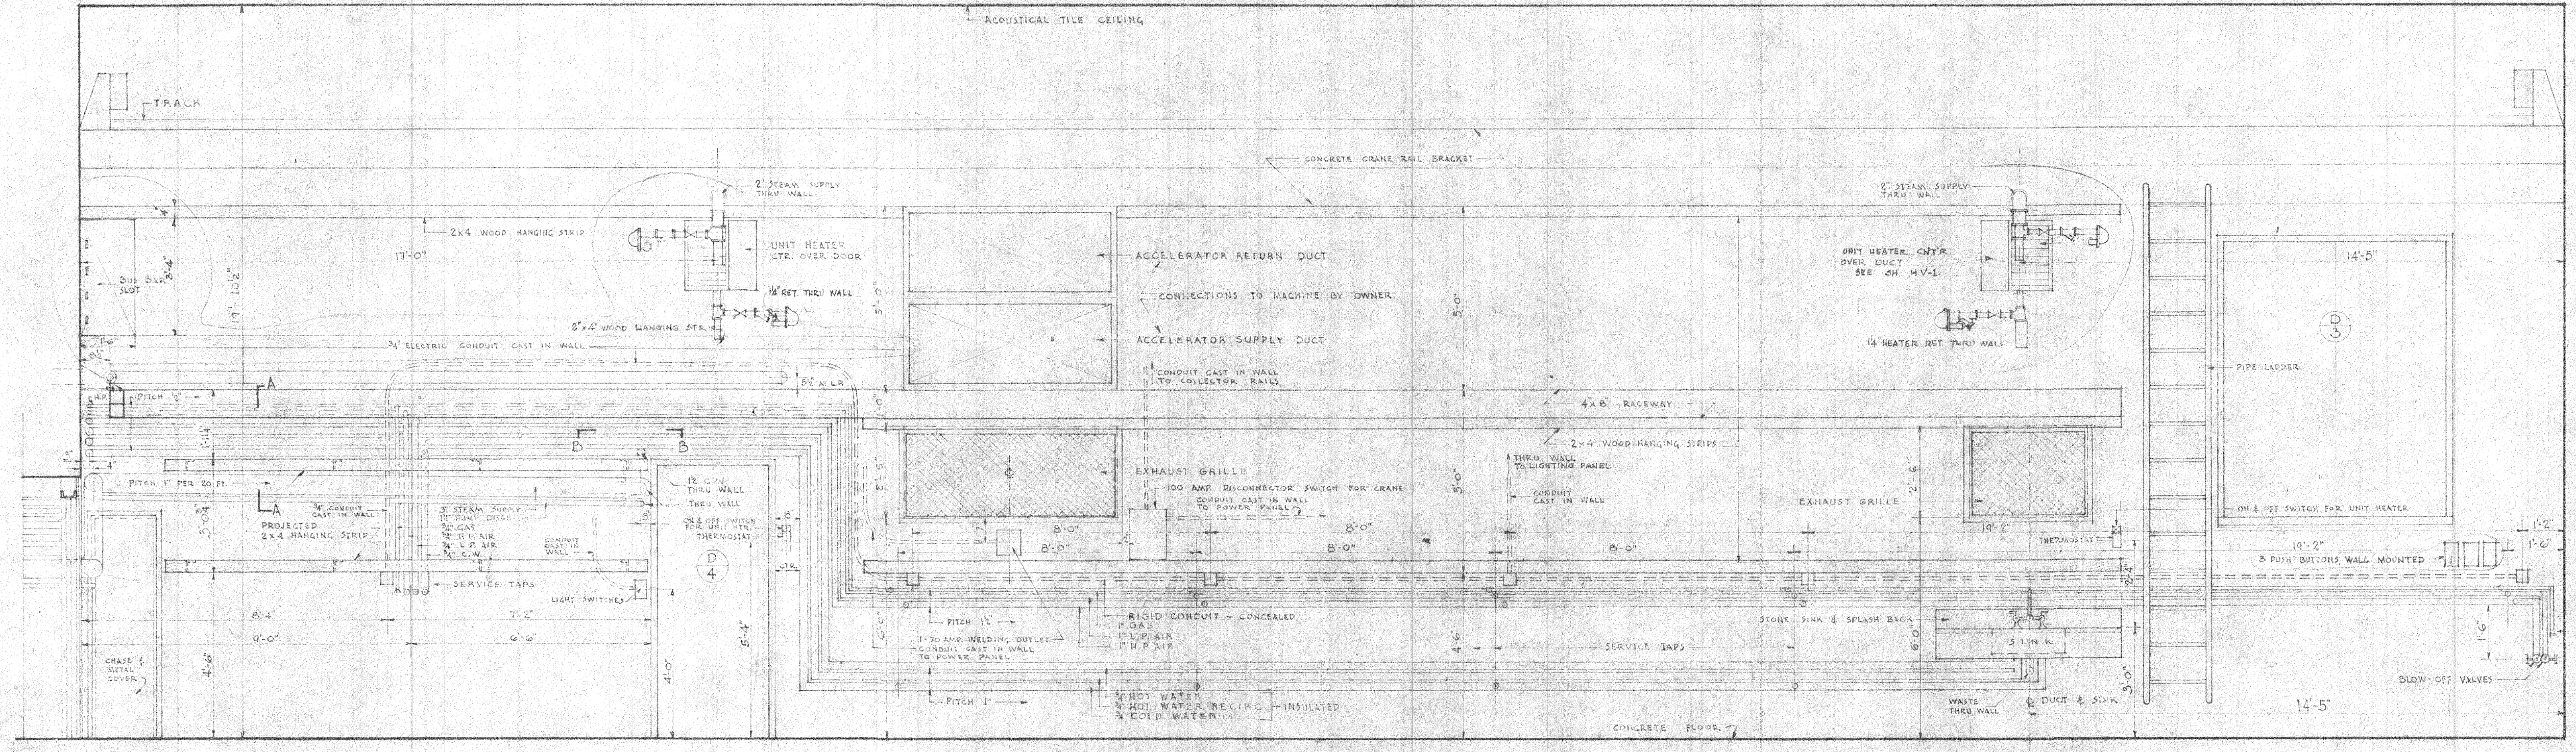

NORTHWEST ELEVATION
SCALE: 3/8" = 1'-0"

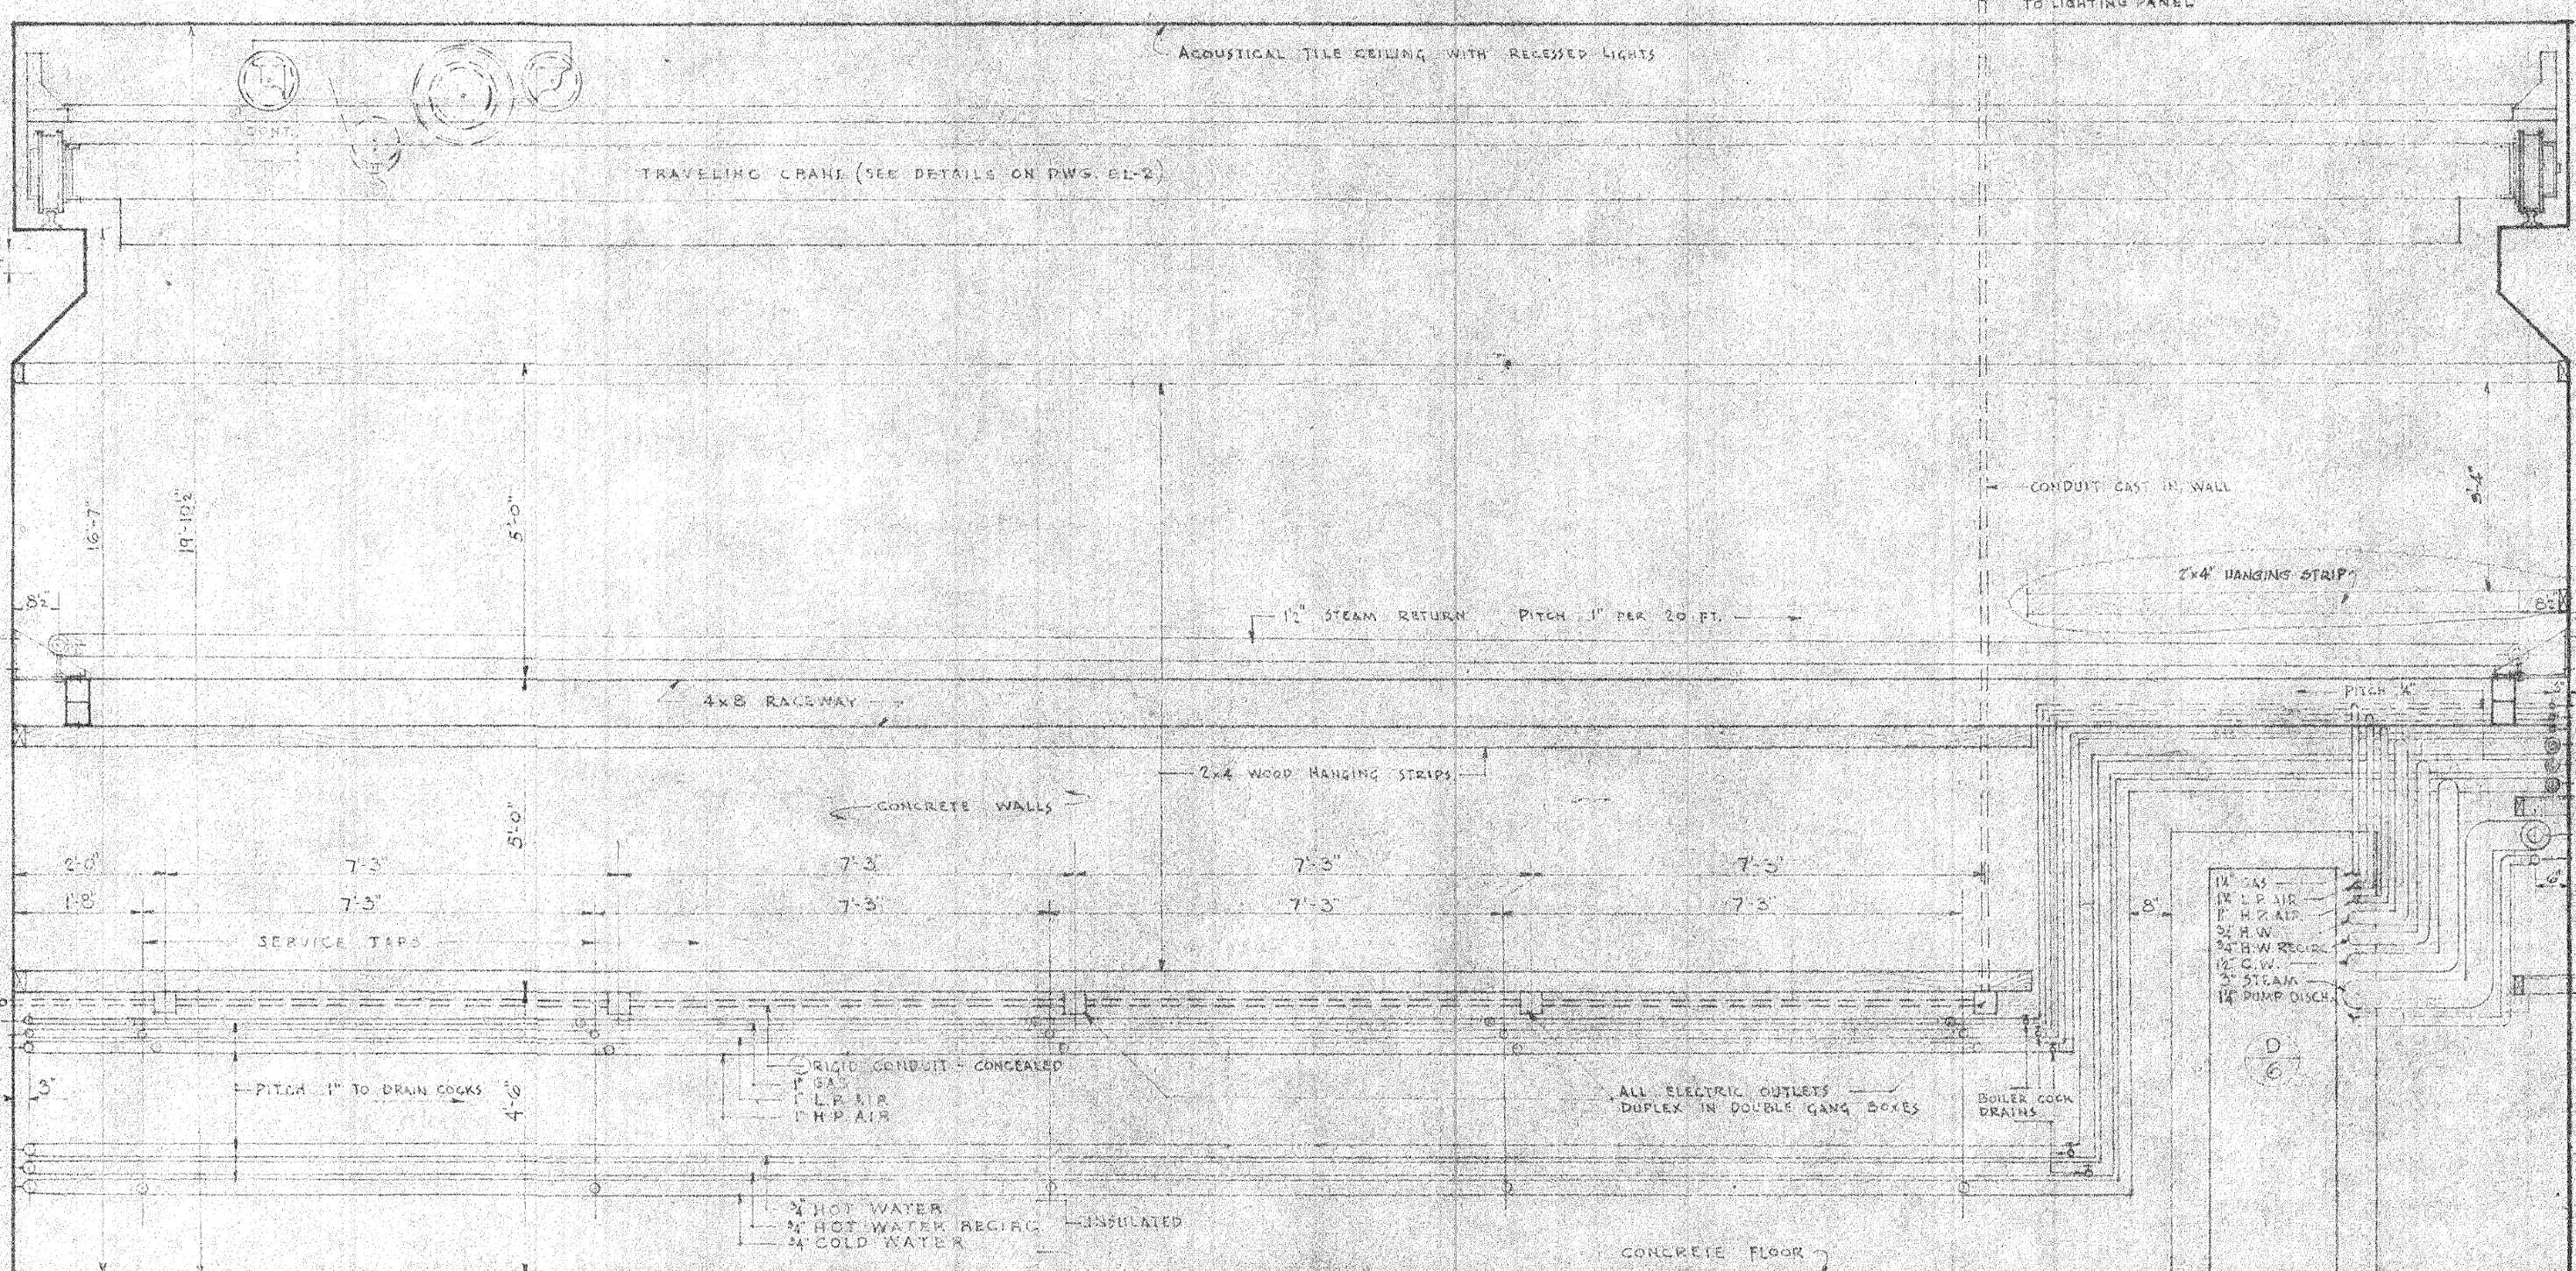


SOUTHWEST ELEVATION
SCALE: 3/8" = 1'-0"

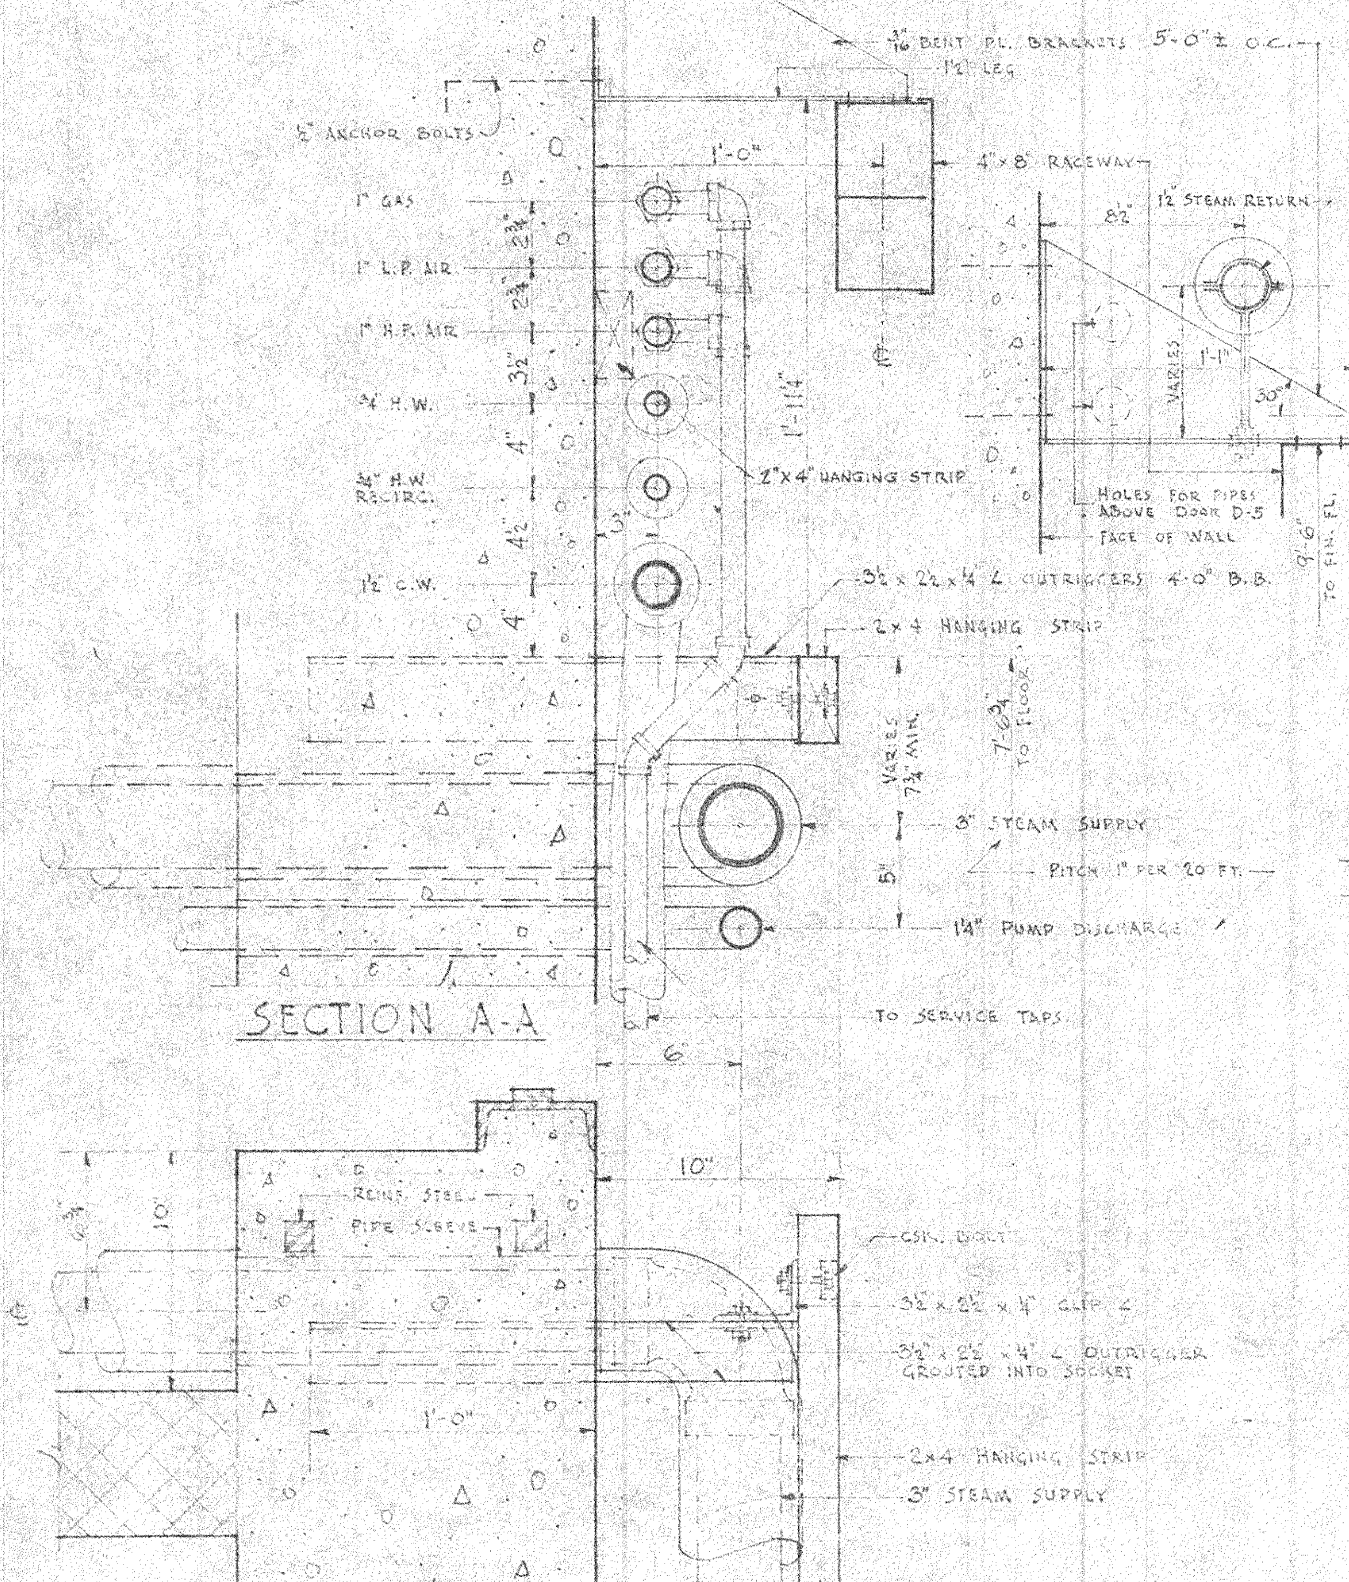

SECTION A-A
SCALE: 1/2" = 1'-0"

PLAN AT B-B
SCALE: 1/2" = 1'-0"

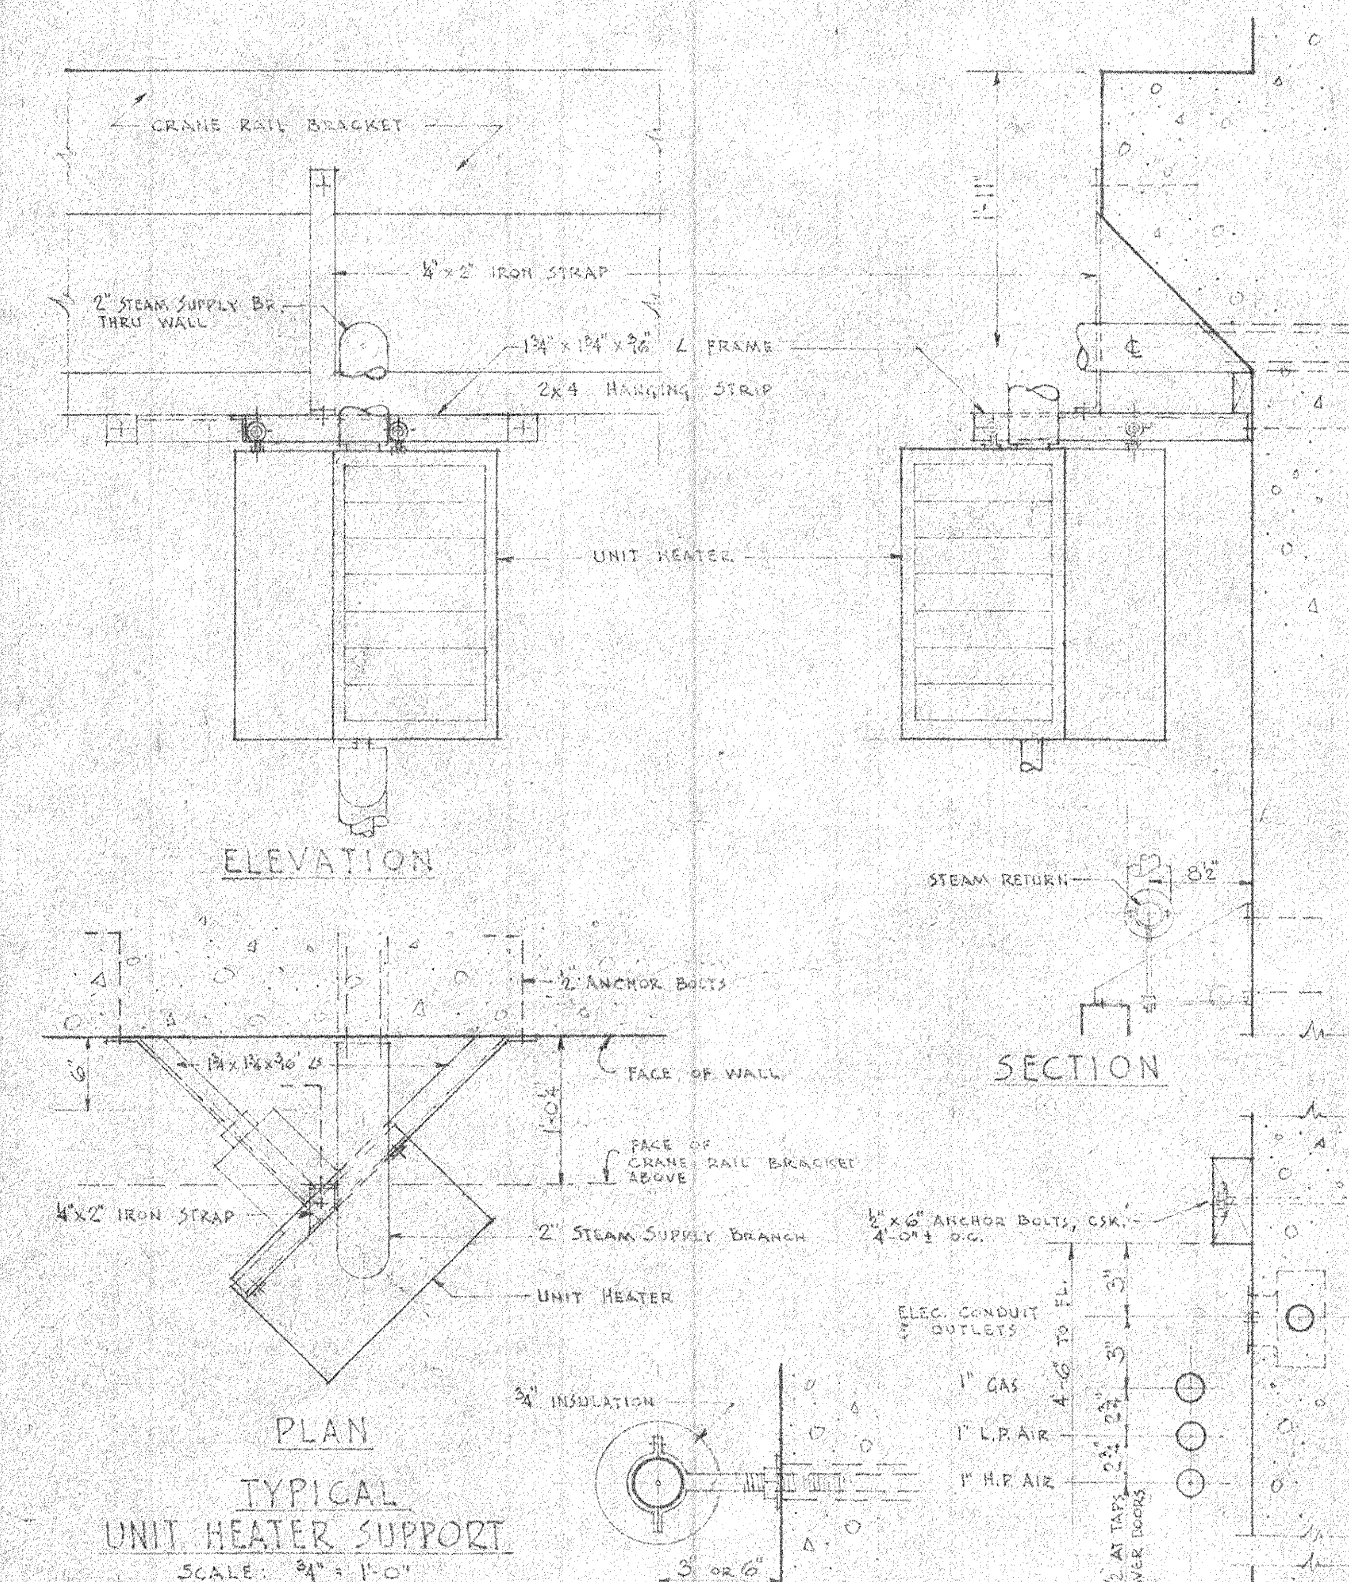

ELEVATION
SCALE: 3/8" = 1'-0"

PLAN
TYPICAL
UNIT HEATER SUPPORT
SCALE: 3/8" = 1'-0"

TYPICAL PIPE SUPPORT
SCALE: 3/8" = 1'-0"

TYPICAL PIPE SPACING
SCALE: 1/2" = 1'-0"
(DIMENSIONS ARE AT TOP OF PIPING)

GENERAL NOTES

1. ALL HORIZONTAL PIPING IN AND OVER SHALL HAVE HANGERS AND SUPPORTS AT LEAST EVERY 10 FEET. PIPING 1" AND LESS SHALL BE SUPPORTED BY HANGERS NOT MORE THAN 8" ON C.C. ALL EXPOSED PIPING TO BE EVENLY SPACED FOR UNIFORM APPEARANCE.
2. ALL ELECTRIC CONDUITS RUN CONCEALED, CAST IN WALLS.
3. LOCATIONS OF ALL SERVICE OUTLETS AND EQUIPMENT SHOWN ON THIS DRAWING SHALL HAVE PRECEDENCE OVER "TYPICAL" PROVISIONS ANY OTHER DRAWING.
4. SECURE 2"x4" WOOD HANGING STRIPS TO WALLS WITH 1/2" ANCHOR BOLTS 4'-0" O.C. NOT TO BE 6" IN WITH WALL BY STUDS.
5. MOUNT THERMOSTATS & OTHER UNIT HEATER CONTROLS 1' OUT FROM WALLS. SEE HIG. OF DET. 27 OF SPEC.



LABORATORY OF NUCLEAR STUDIES
CORNELL UNIVERSITY - ITHACA, N. Y.
SKIDMORE OWINGS & MERRILL
ARCHITECTS
5 EAST 57 STREET - NEW YORK, N. Y.

ACCELERATOR BUILDING
ACCELERATOR R.M. ELEVATIONS

DRAWN	J.C.	DATE	5-9-47	DRAWING NUMBER	A7a
CHECKED	J.S.	SCALE	AS NOTED		